

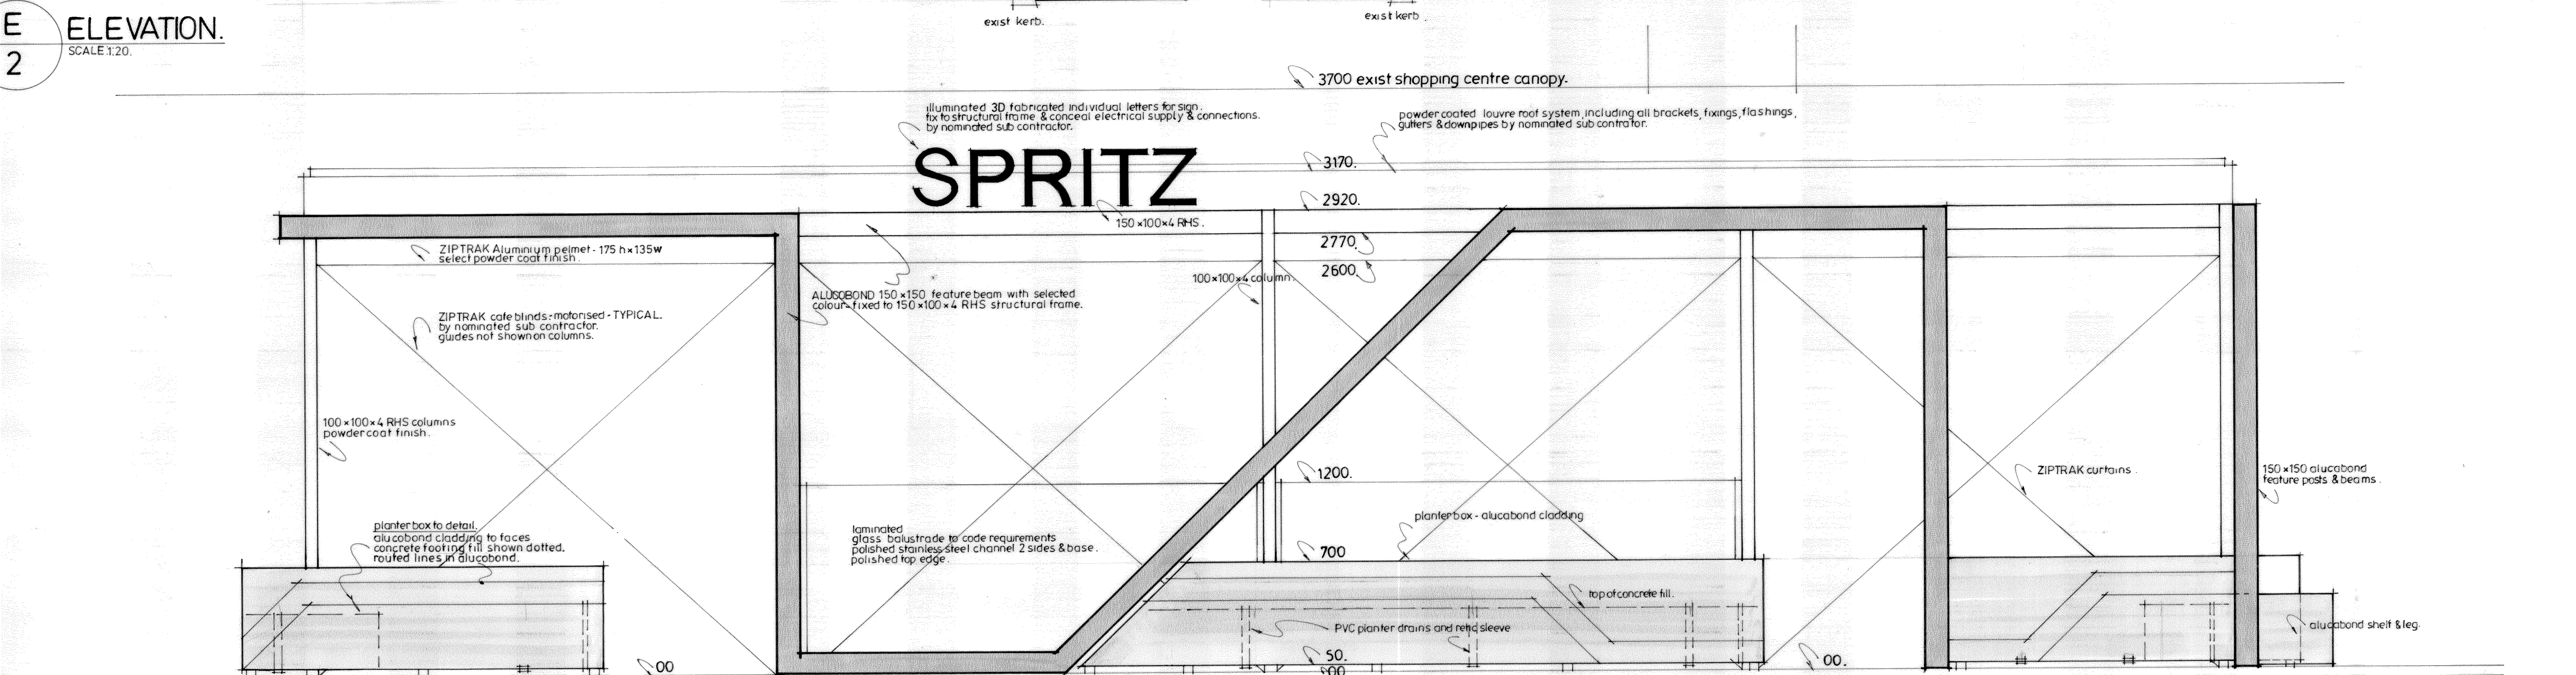


ALL STRUCTURAL STEELWORK TO BE FULLY HOT DIPPED GALVANISED - SELECT POWDER COAT FINISH.


- THIS ENTIRE STRUCTURE HAS BEEN DESIGNED TO MAKE IT EASILY REMOVABLE. - the use of silicone is prohibited unless absolutely necessary and approved.

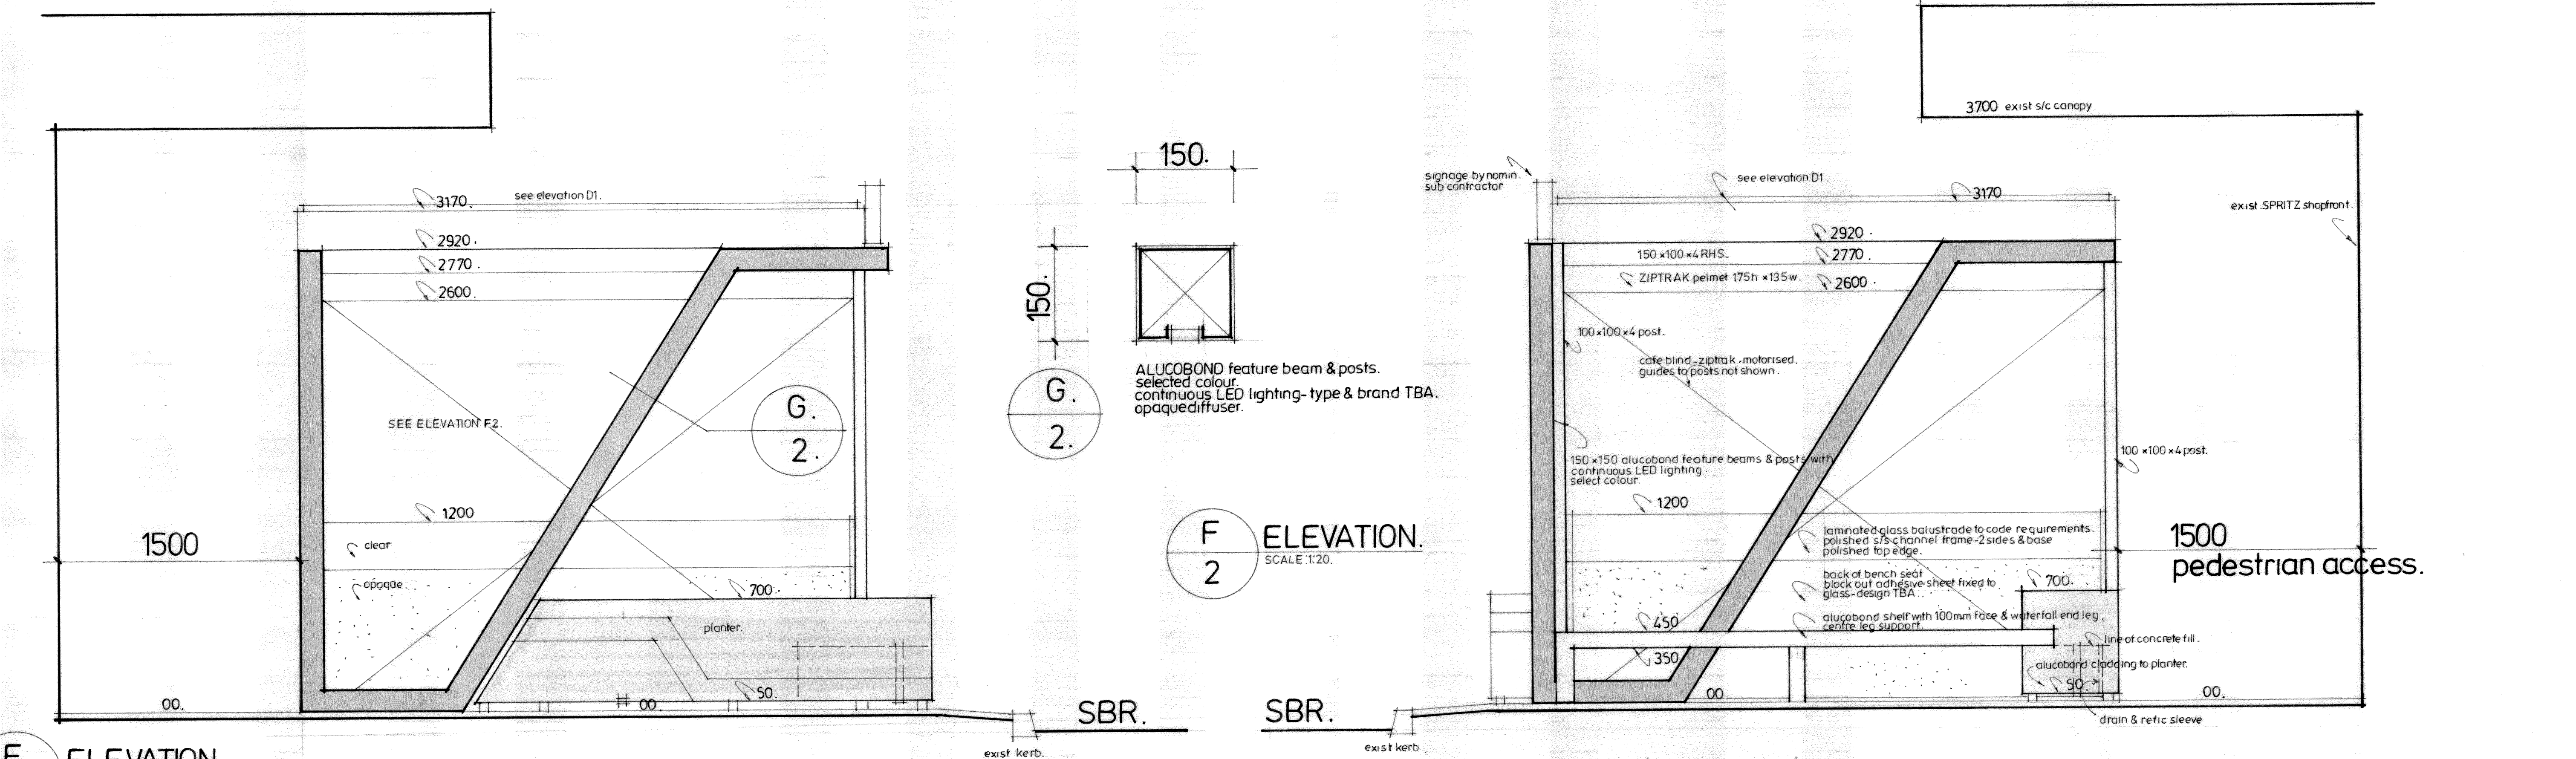


Amendments	Date	Item	No.
PROJECT			
SPRITZ.			
148 SCARBOROUGH BEACH ROAD, MT HAWTHORN.			
 MCARTNEY & ASSOCIATES PTY LTD Reg. Builders: 100779 m: 0419 864 117 e: mcartney@inet.net.au 16 Angelico St, Woodlands 6018 mcartneyandassociates.net	Date: DEC 10.	Job No.	Drawing No.
	Scale: 1:20.		2.
	Check all dimensions on site prior to commencement		

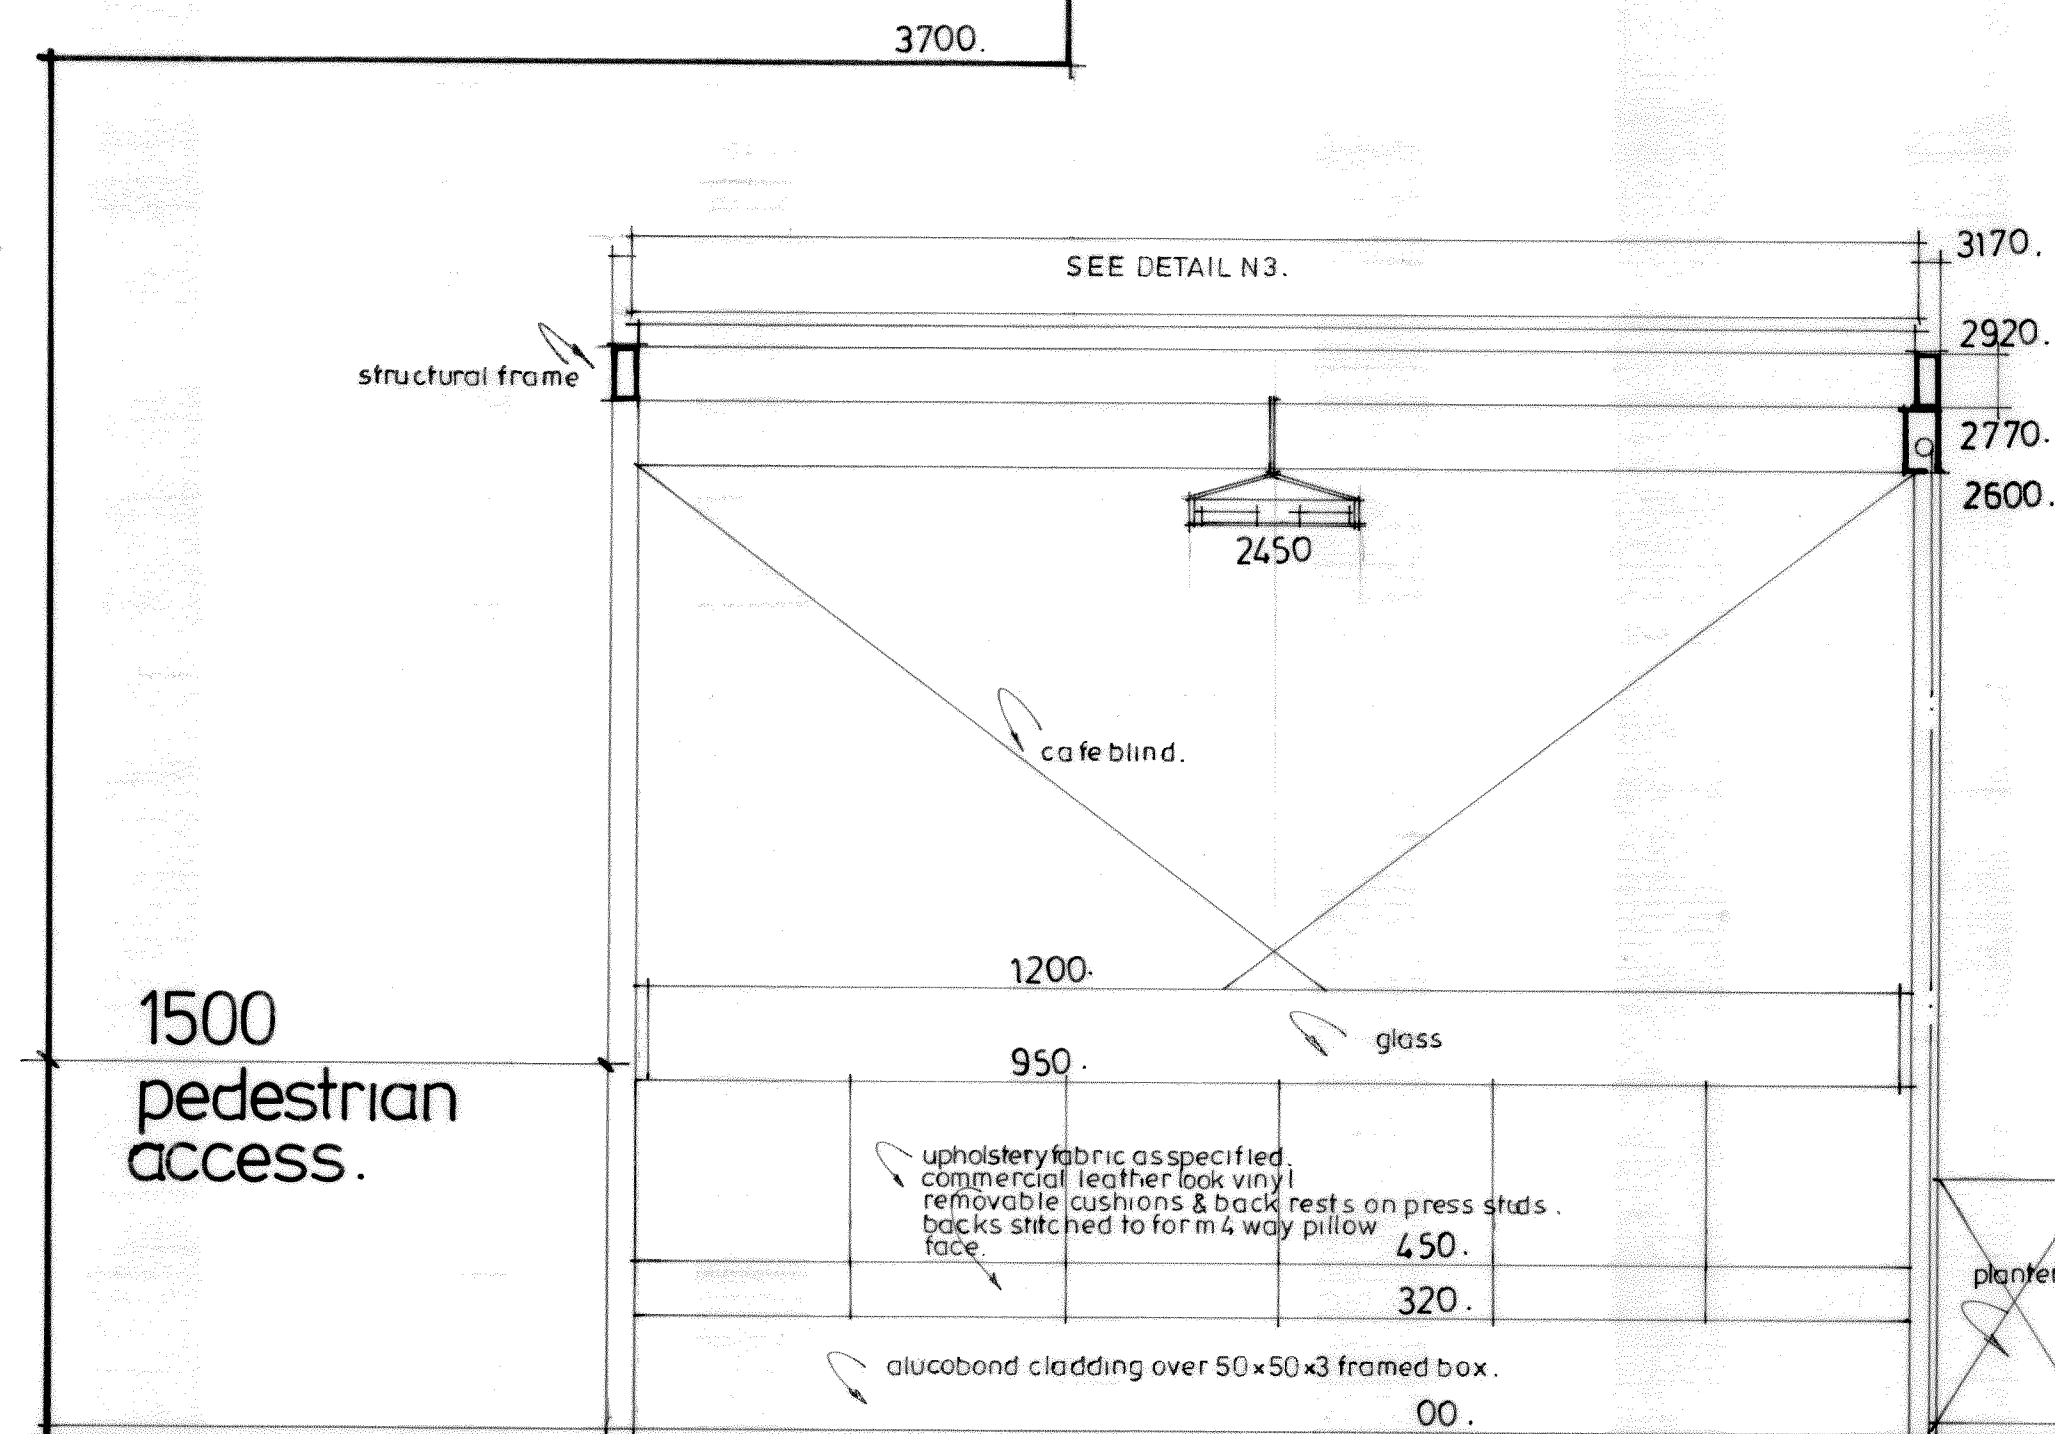


K. SECTION.
3. SCALE 1:20.

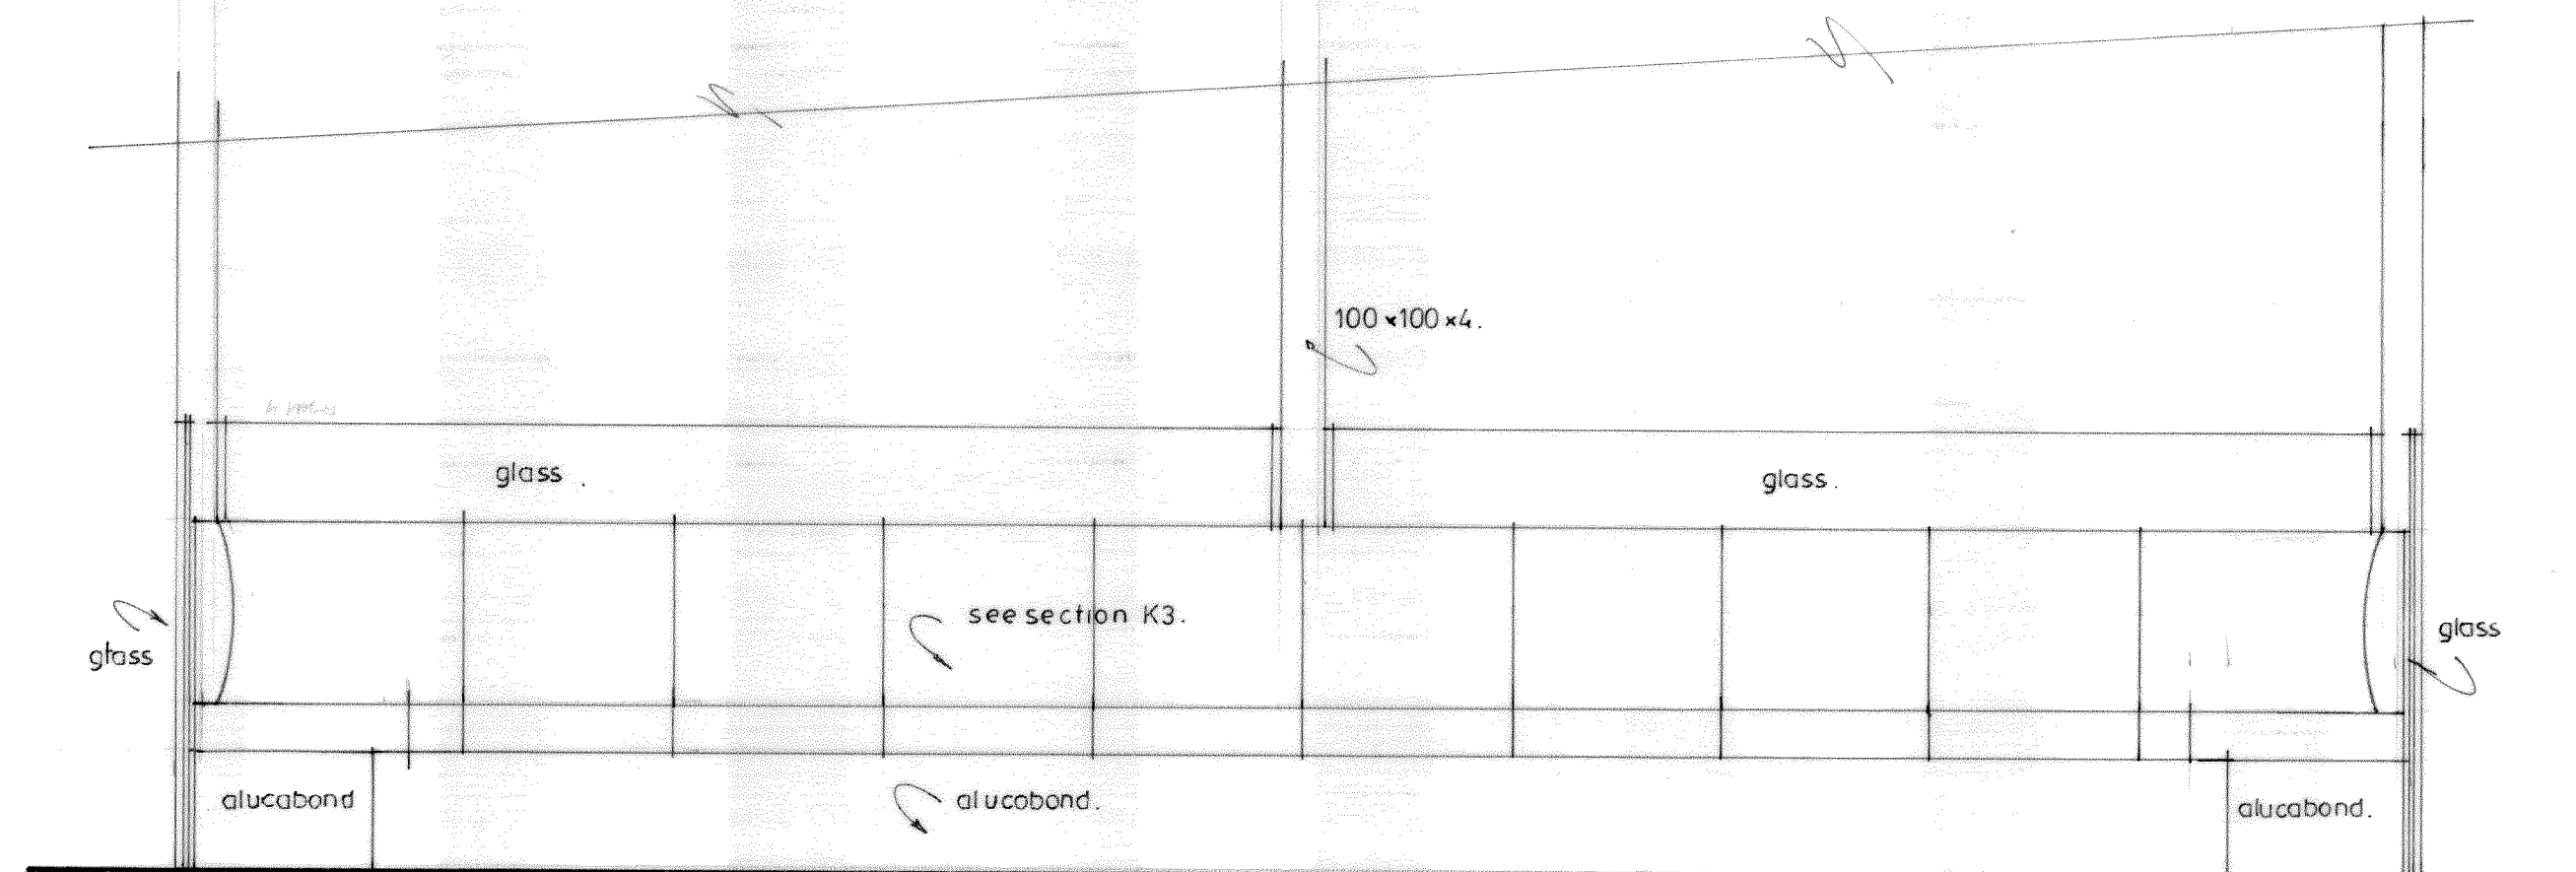


M. SECTION.
3. SCALE 1:20.

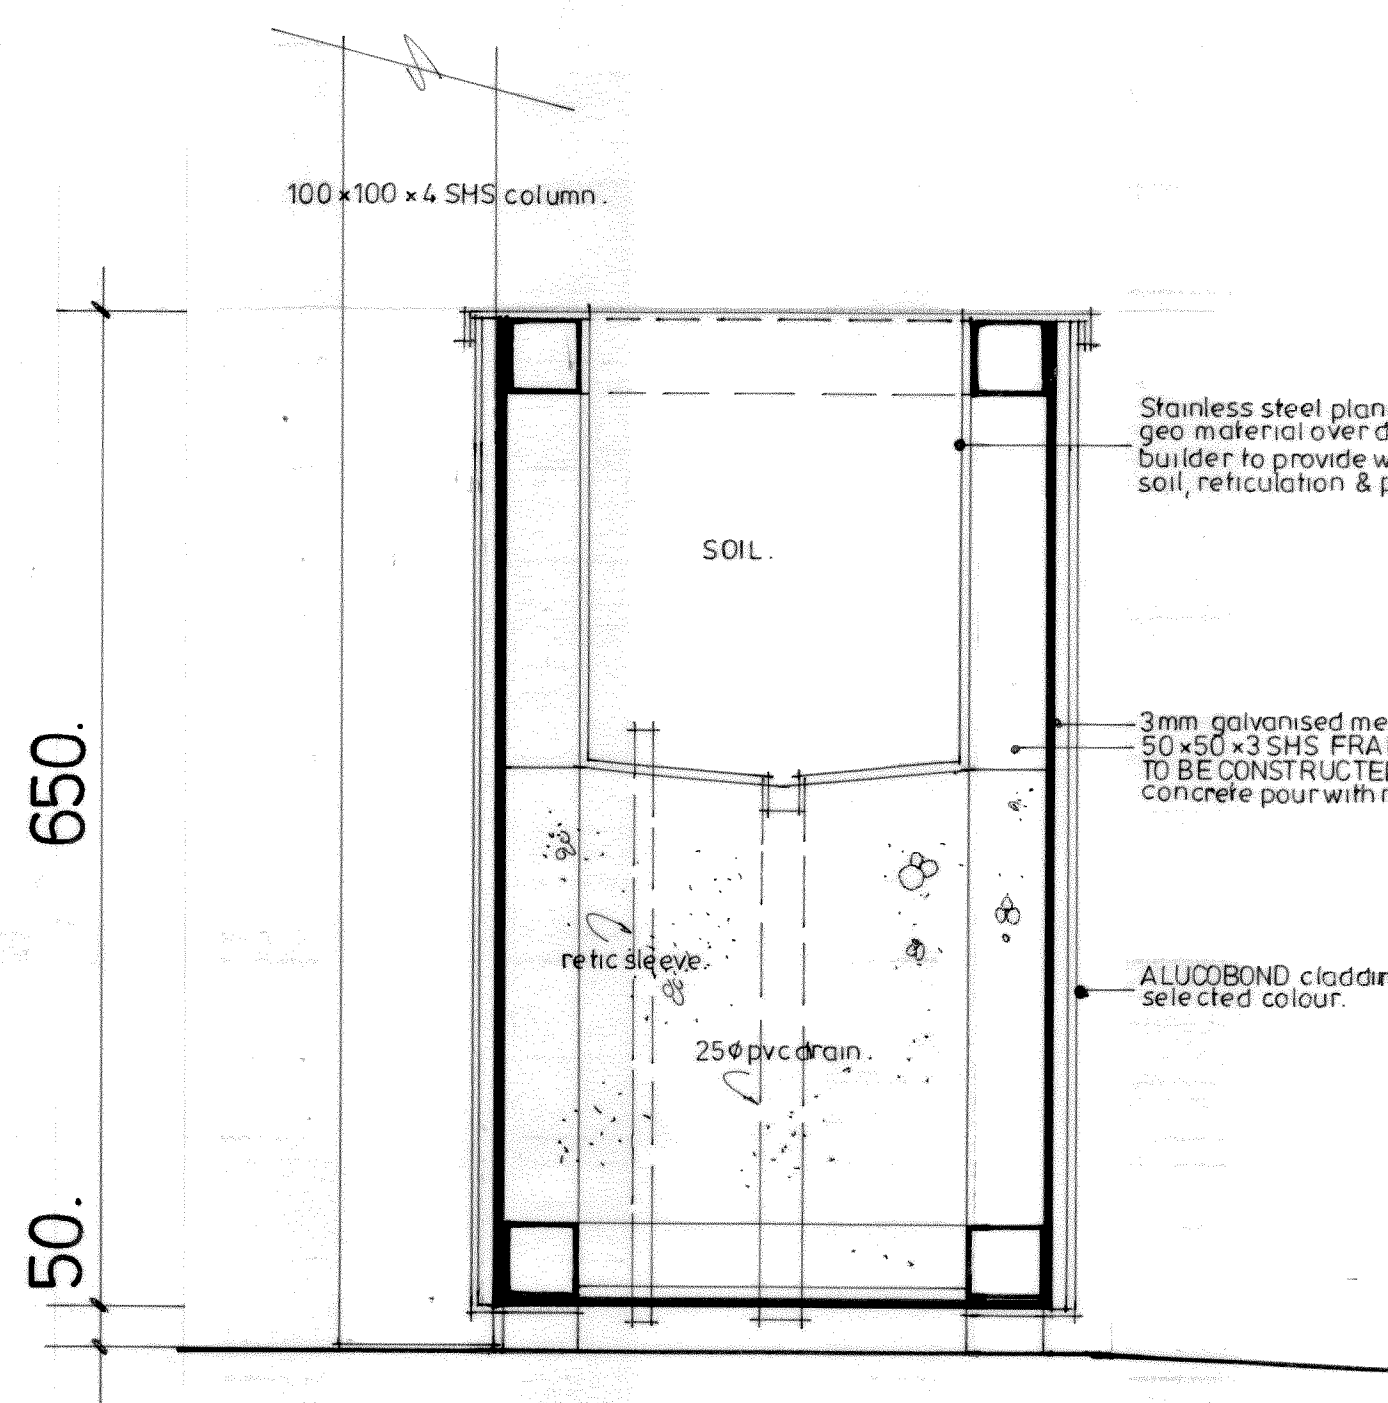


H. SECTION - PLANTER.
3. SCALE 1:5.

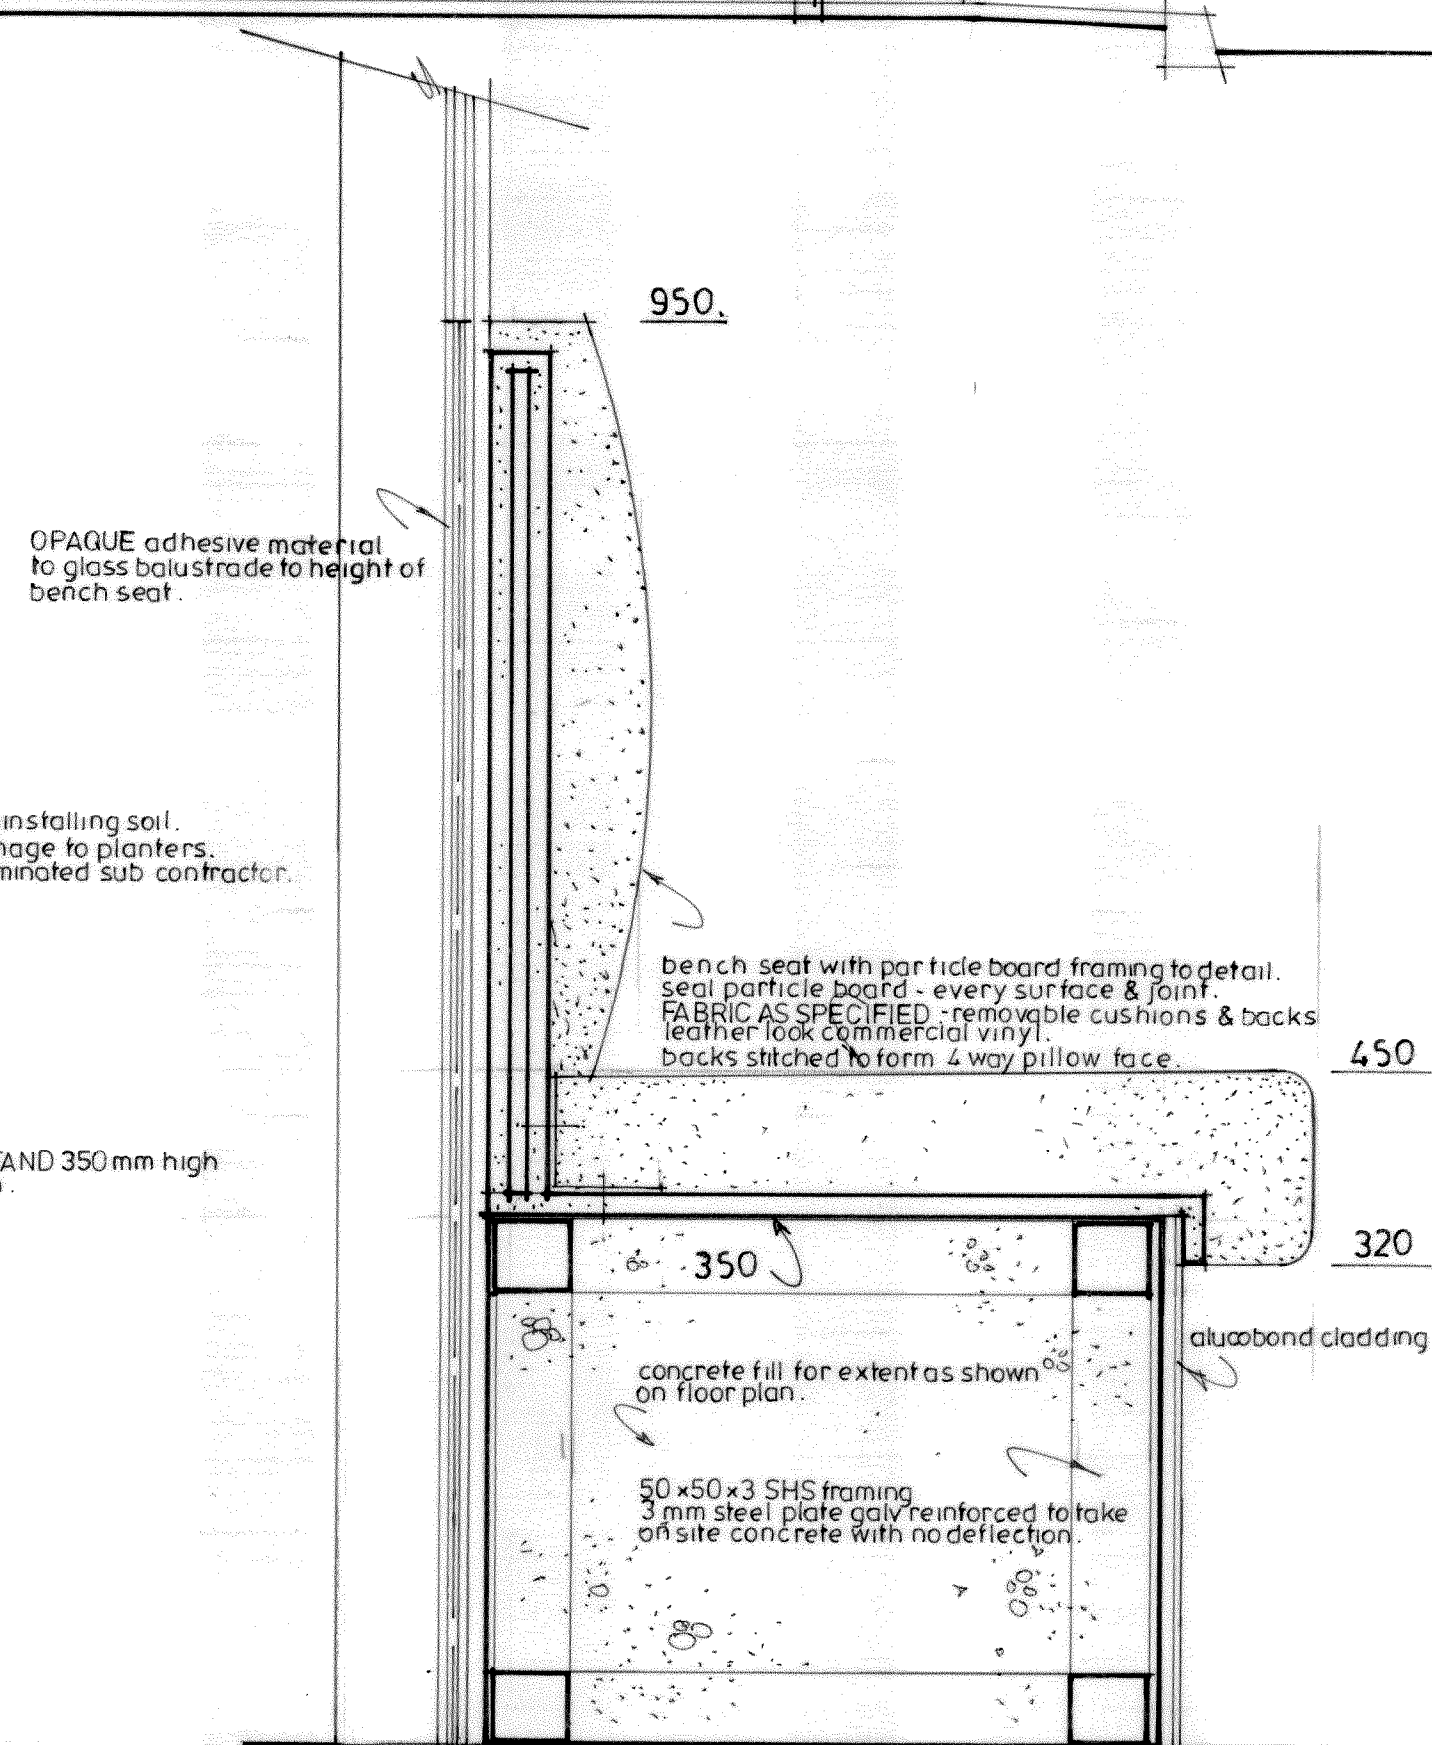

J. SECTION - BENCH SEAT.
3. SCALE 1:5.

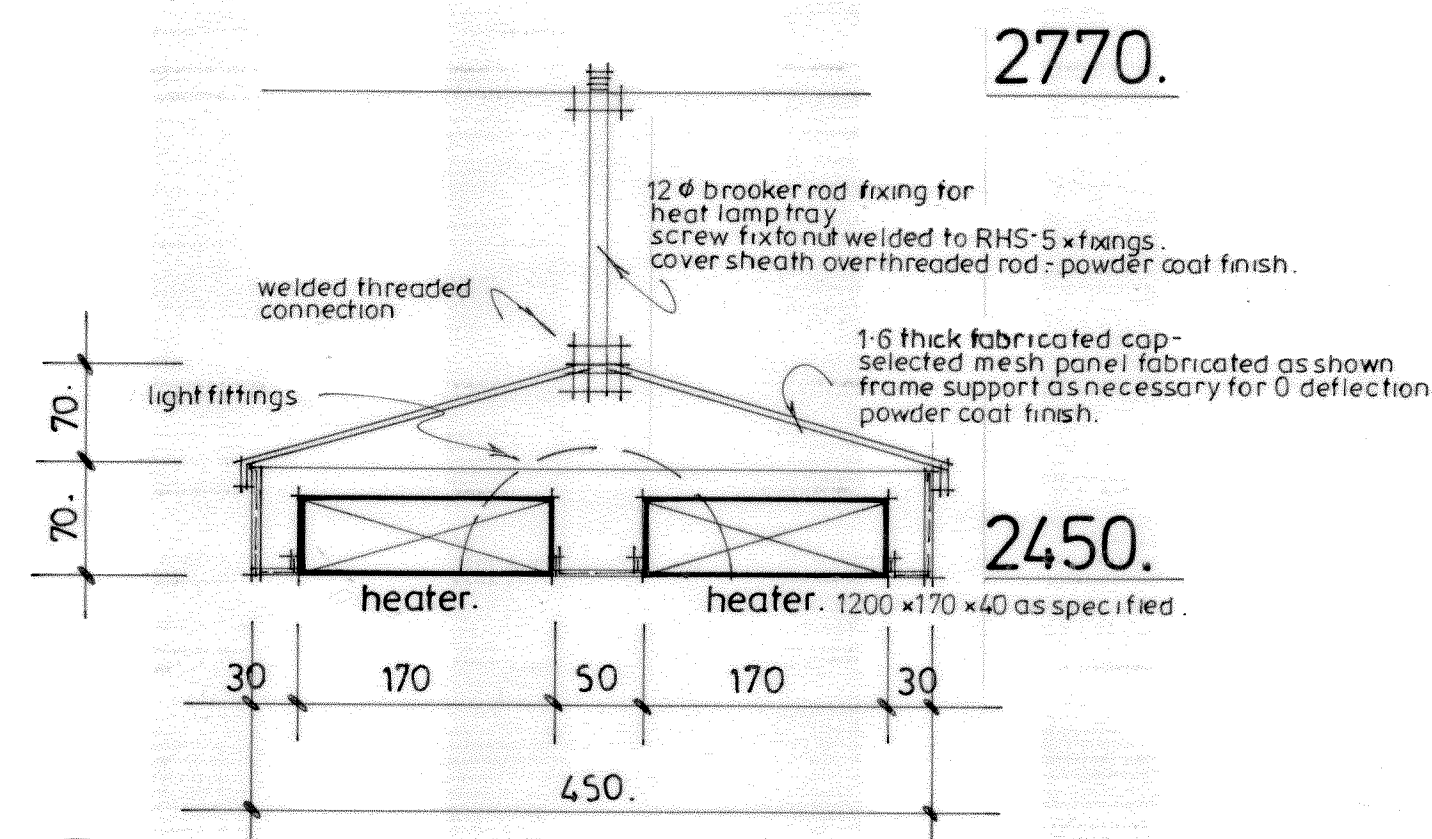


L. SECTION - LIGHTING & HEATING TRAY.
3. SCALE 1:5.

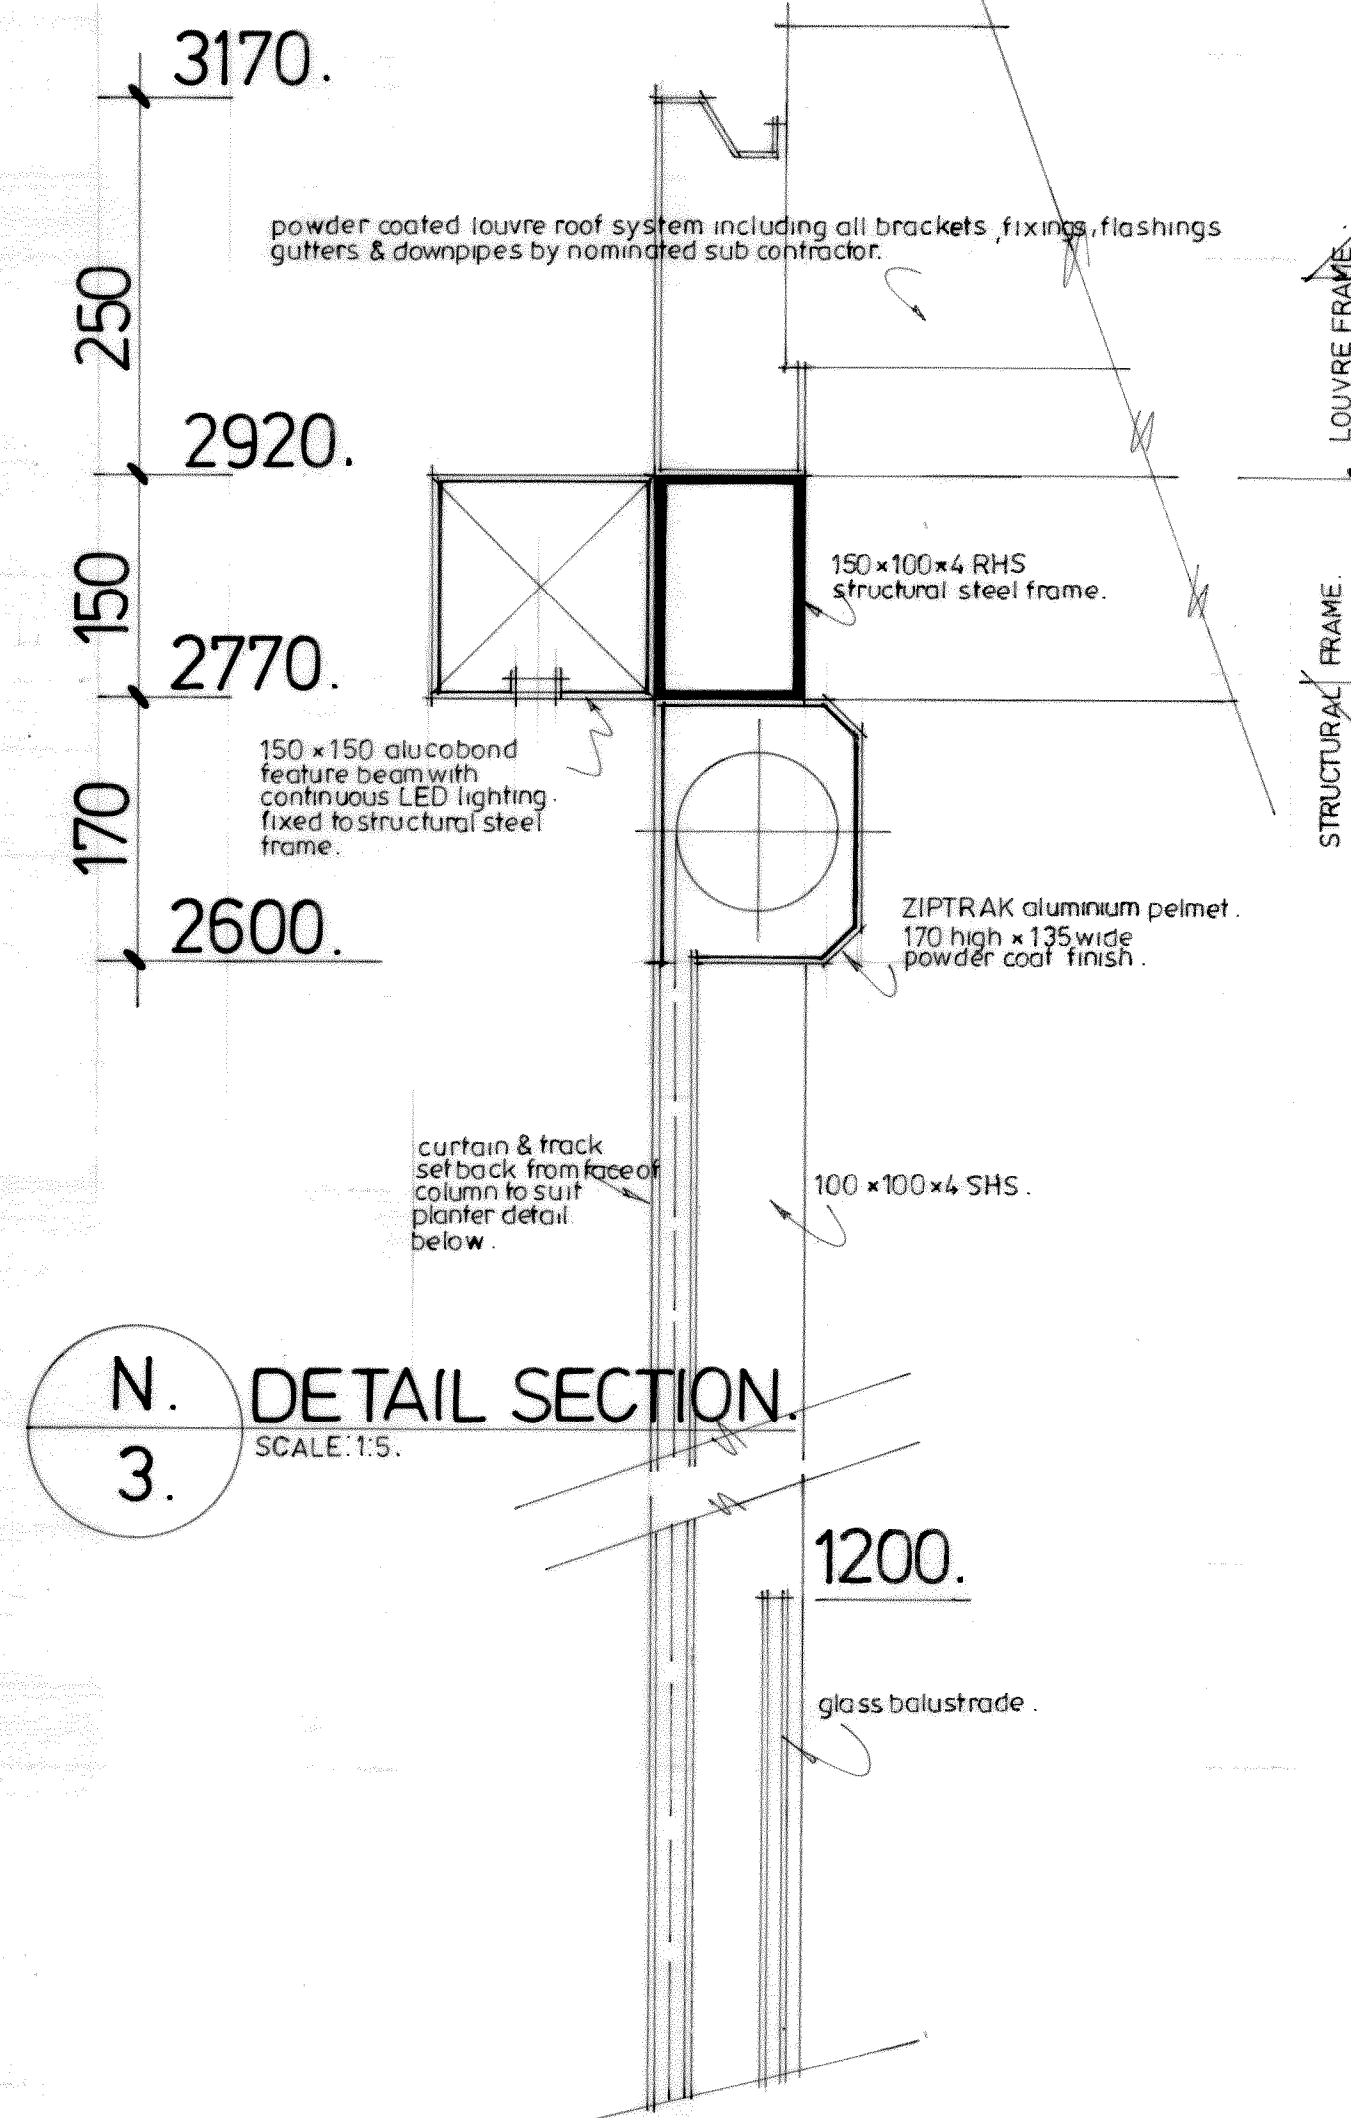

N. DETAIL SECTION.
3. SCALE 1:5.

Amendments	Date	Item	No.
PROJECT			
SPRITZ.			
148 SCARBOROUGH BEACH ROAD MTHAWTHORN			
MCCARTNEY & ASSOCIATES PTY LTD			
Reg. Builders: 100779			
m: 0419 864 117 e: mcartney@inet.net.au			
16 Angelico St, Woodlands 6018 mcartneyandassociates.net			
Date:	DEC 18	Job No.	
Scale:	1:5 1:20.		
Check all dimensions on site prior to commencement			

EXISTING SPRITZ CAFE.

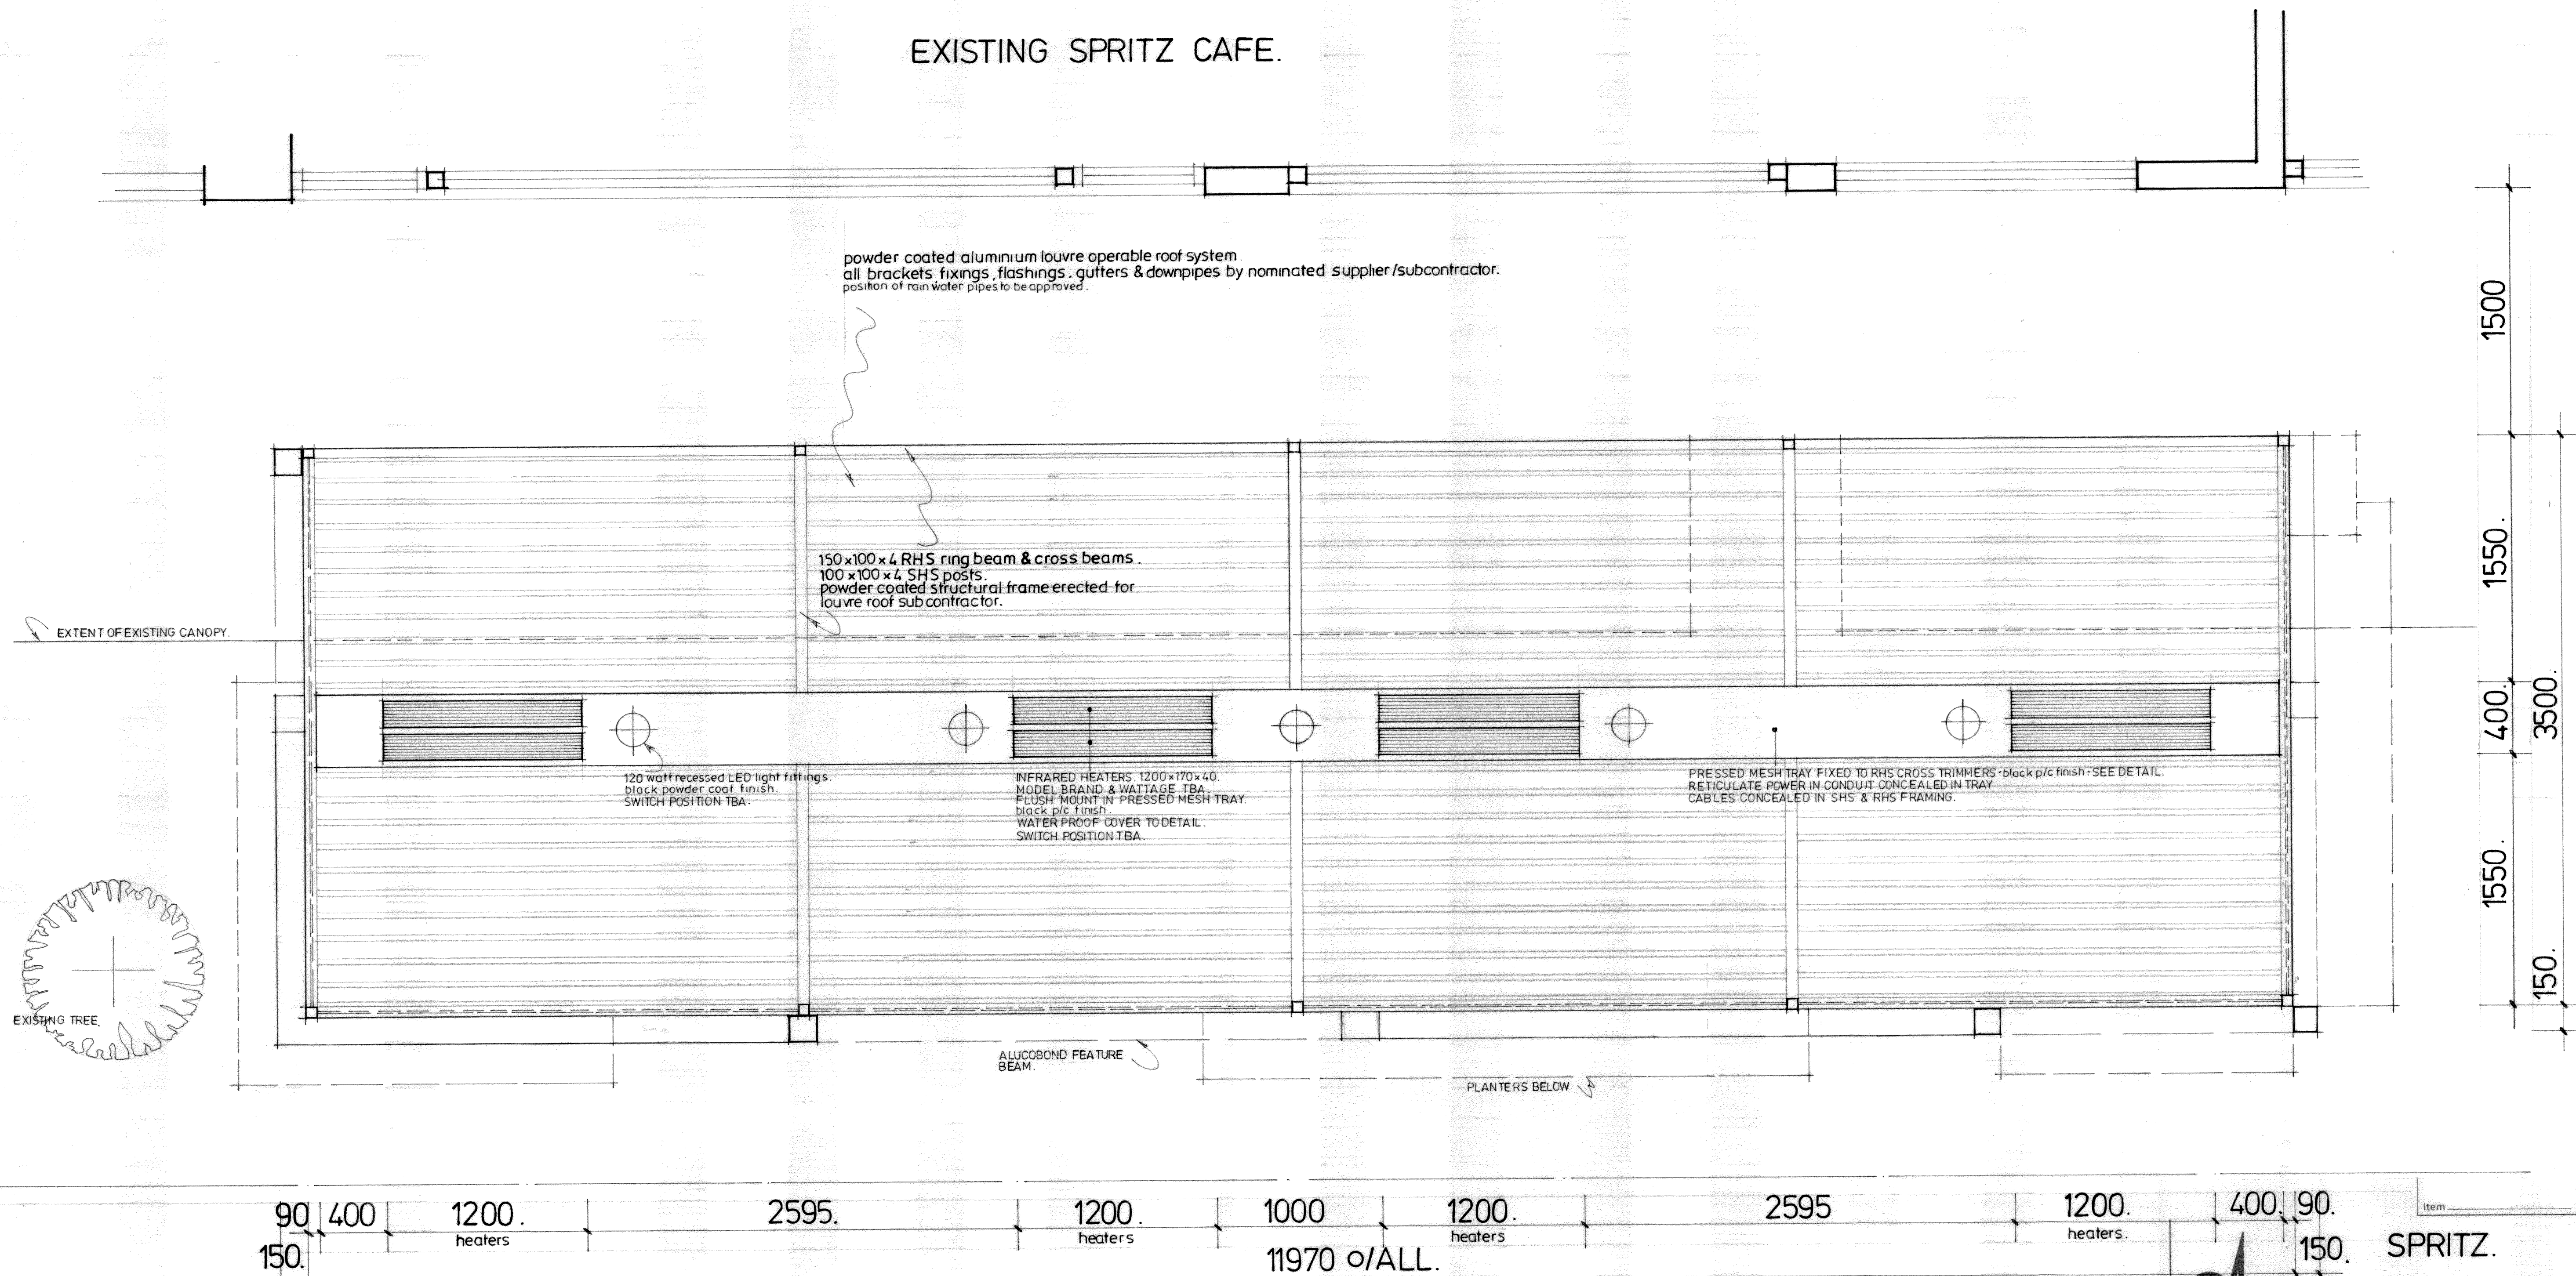

P. 4. CEILING & LIGHTING PLAN.
SCALE: 1:20.

MCARTNEY &
ASSOCIATES PTY LTD
Reg. Builders: 100779
m: 0419 864 117
e: mcartney@inet.net.au
16 Angelico St, Woodlands 6018
mcartneyandassociates.net

SPRITZ.
148 SCARBOROUGH BEACH
ROAD, MT HAWTHORN.

Date: DEC 2018
Scale: 1:20
Job No.
Drawing No.
4

Check all dimensions on site prior to commencement